



CONTINUED FROM DWG. D-14153RS-61-001

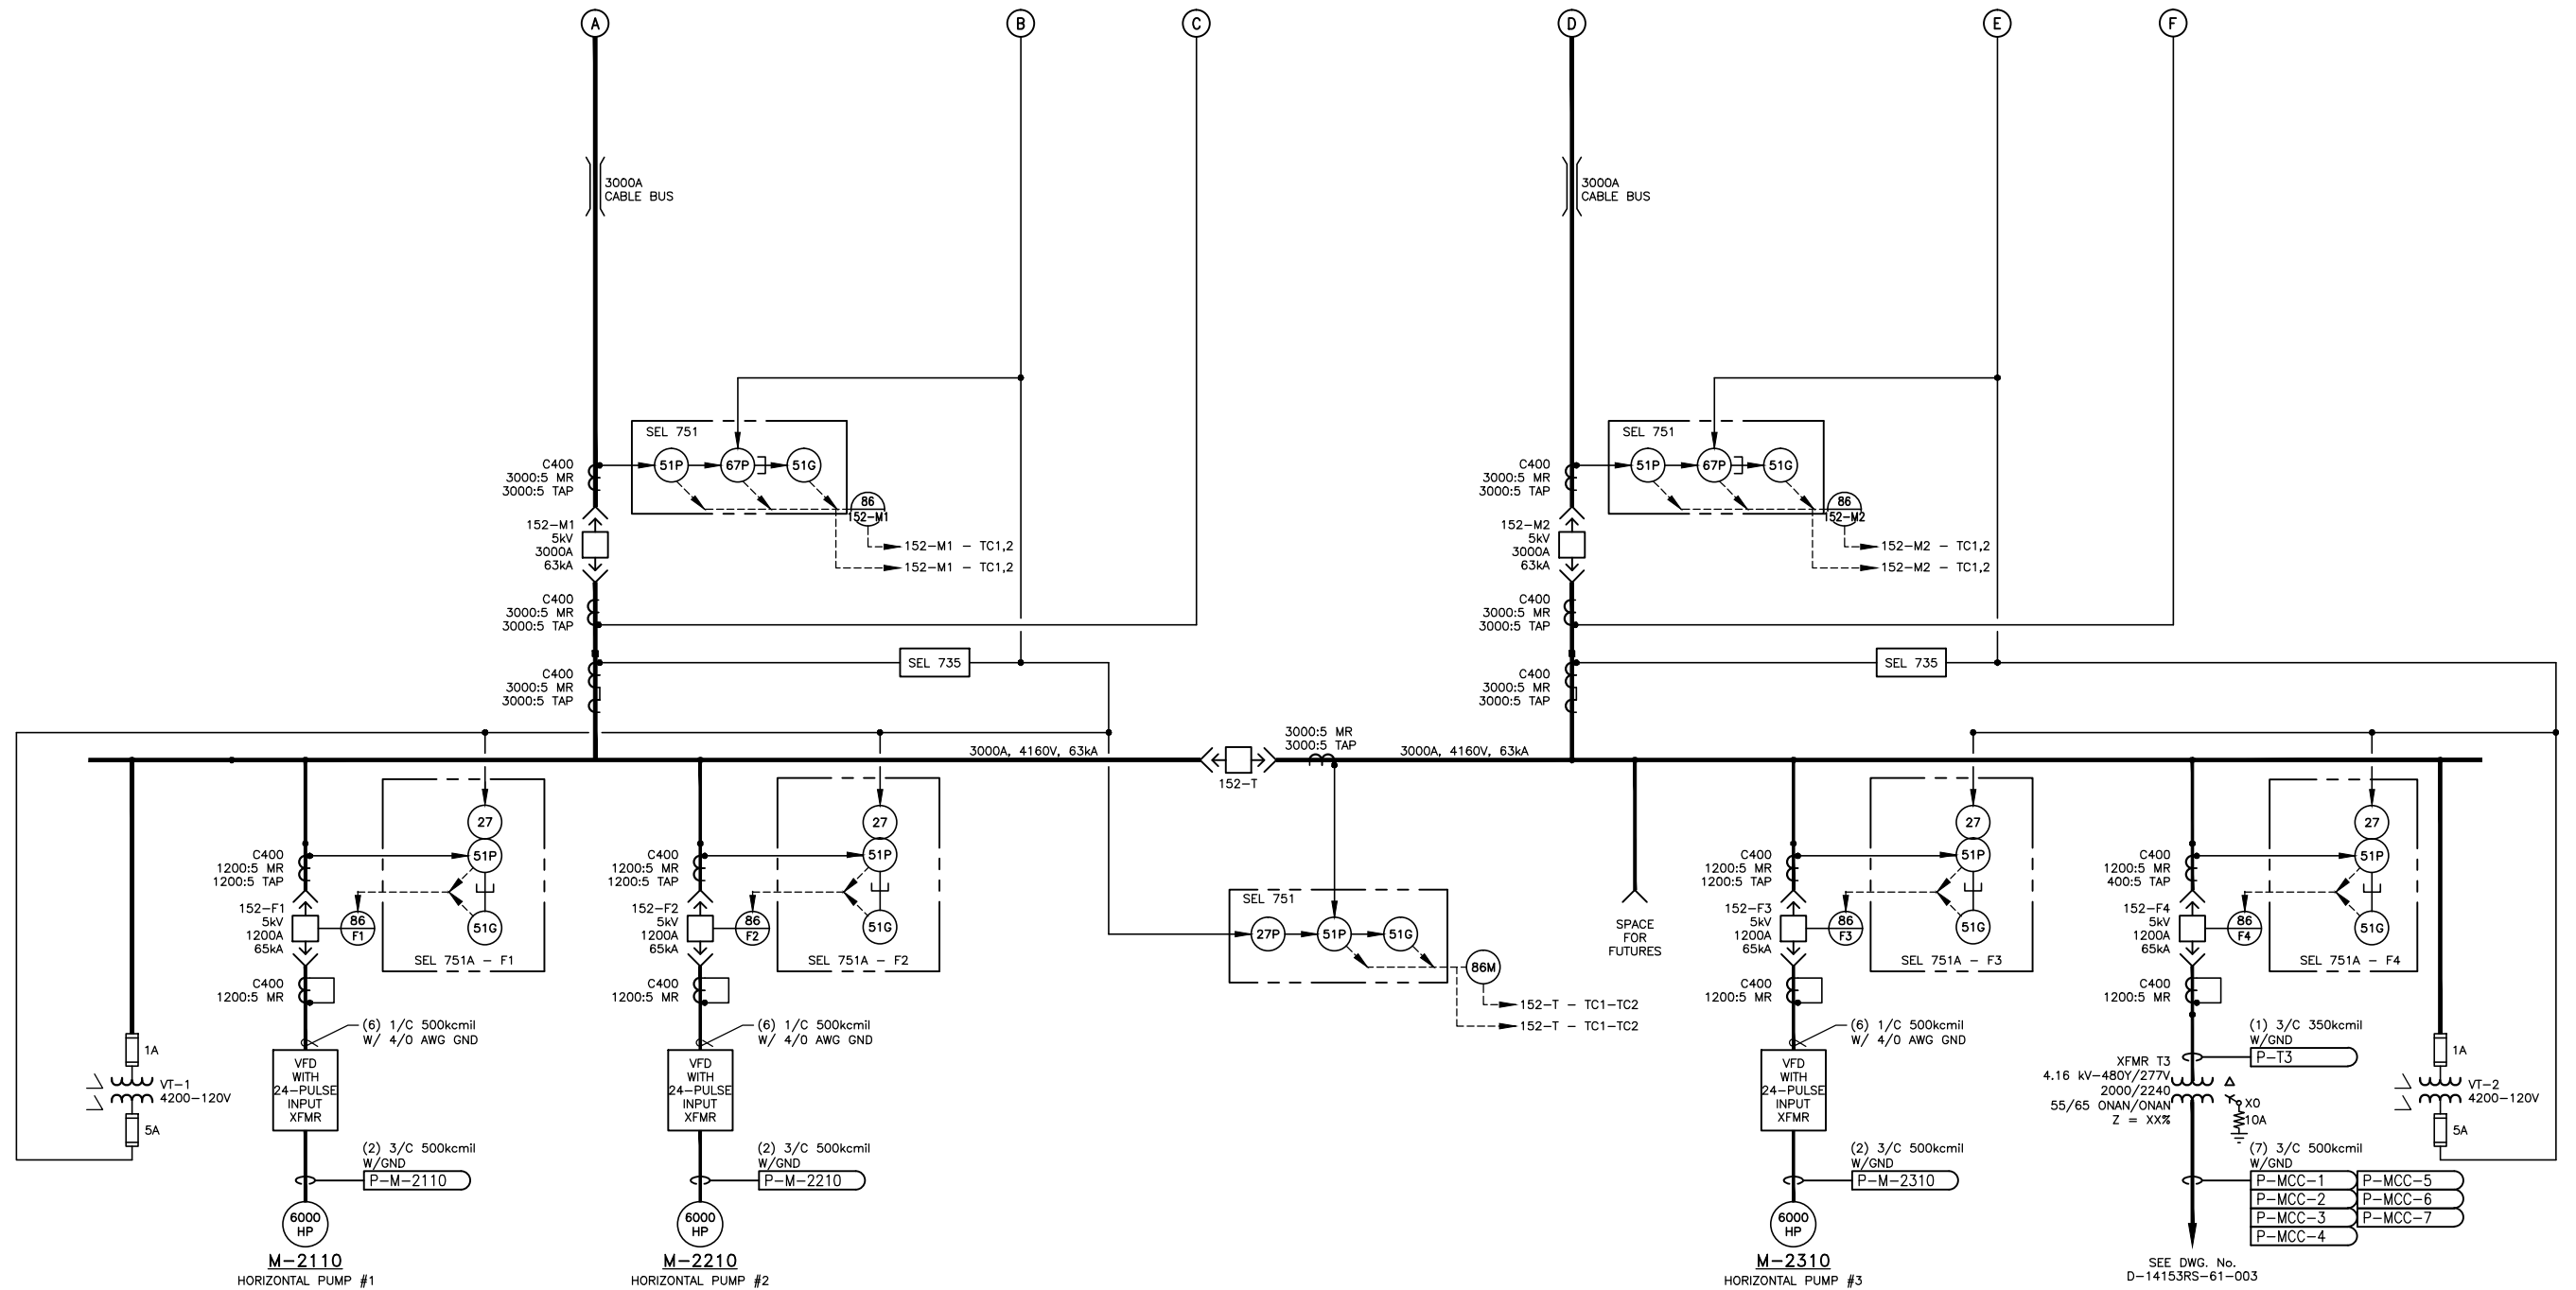

DWG. NO.	REFERENCE DRAWING TITLE	NO.	REVISION - DESCRIPTION	BY	DATE	CHK'D	APP'D	DWG. STATUS	CHECKED BY	DATE	APPROVED BY	DATE	PL./STA. NO. ACCOUNT NO.	 M S BENBOW AND ASSOCIATES METAIRIE, LA	DAKOTA ACCESS PIPELINE REDFIELD STATION ELECTRICAL OVERALL ONE-LINE DIAGRAM SHEET 2 OF 2	PROJECT NO.	
								PREL.Y					CONSTRUCTION YEAR			PREVIOUS DWG. NO.	
								BID					DESIGN BY			DATE	SHEET 1 OF 1
								CONSTR.					DRAWN BY			DATE	DWG. NO.
								CADD	FILE NAME:	D-14153RS-61-001.dwg	SCALE:	NONE			D-14153RS-61-002		

14153 1 TML 8/4/2015 9:07 AM

HOLD

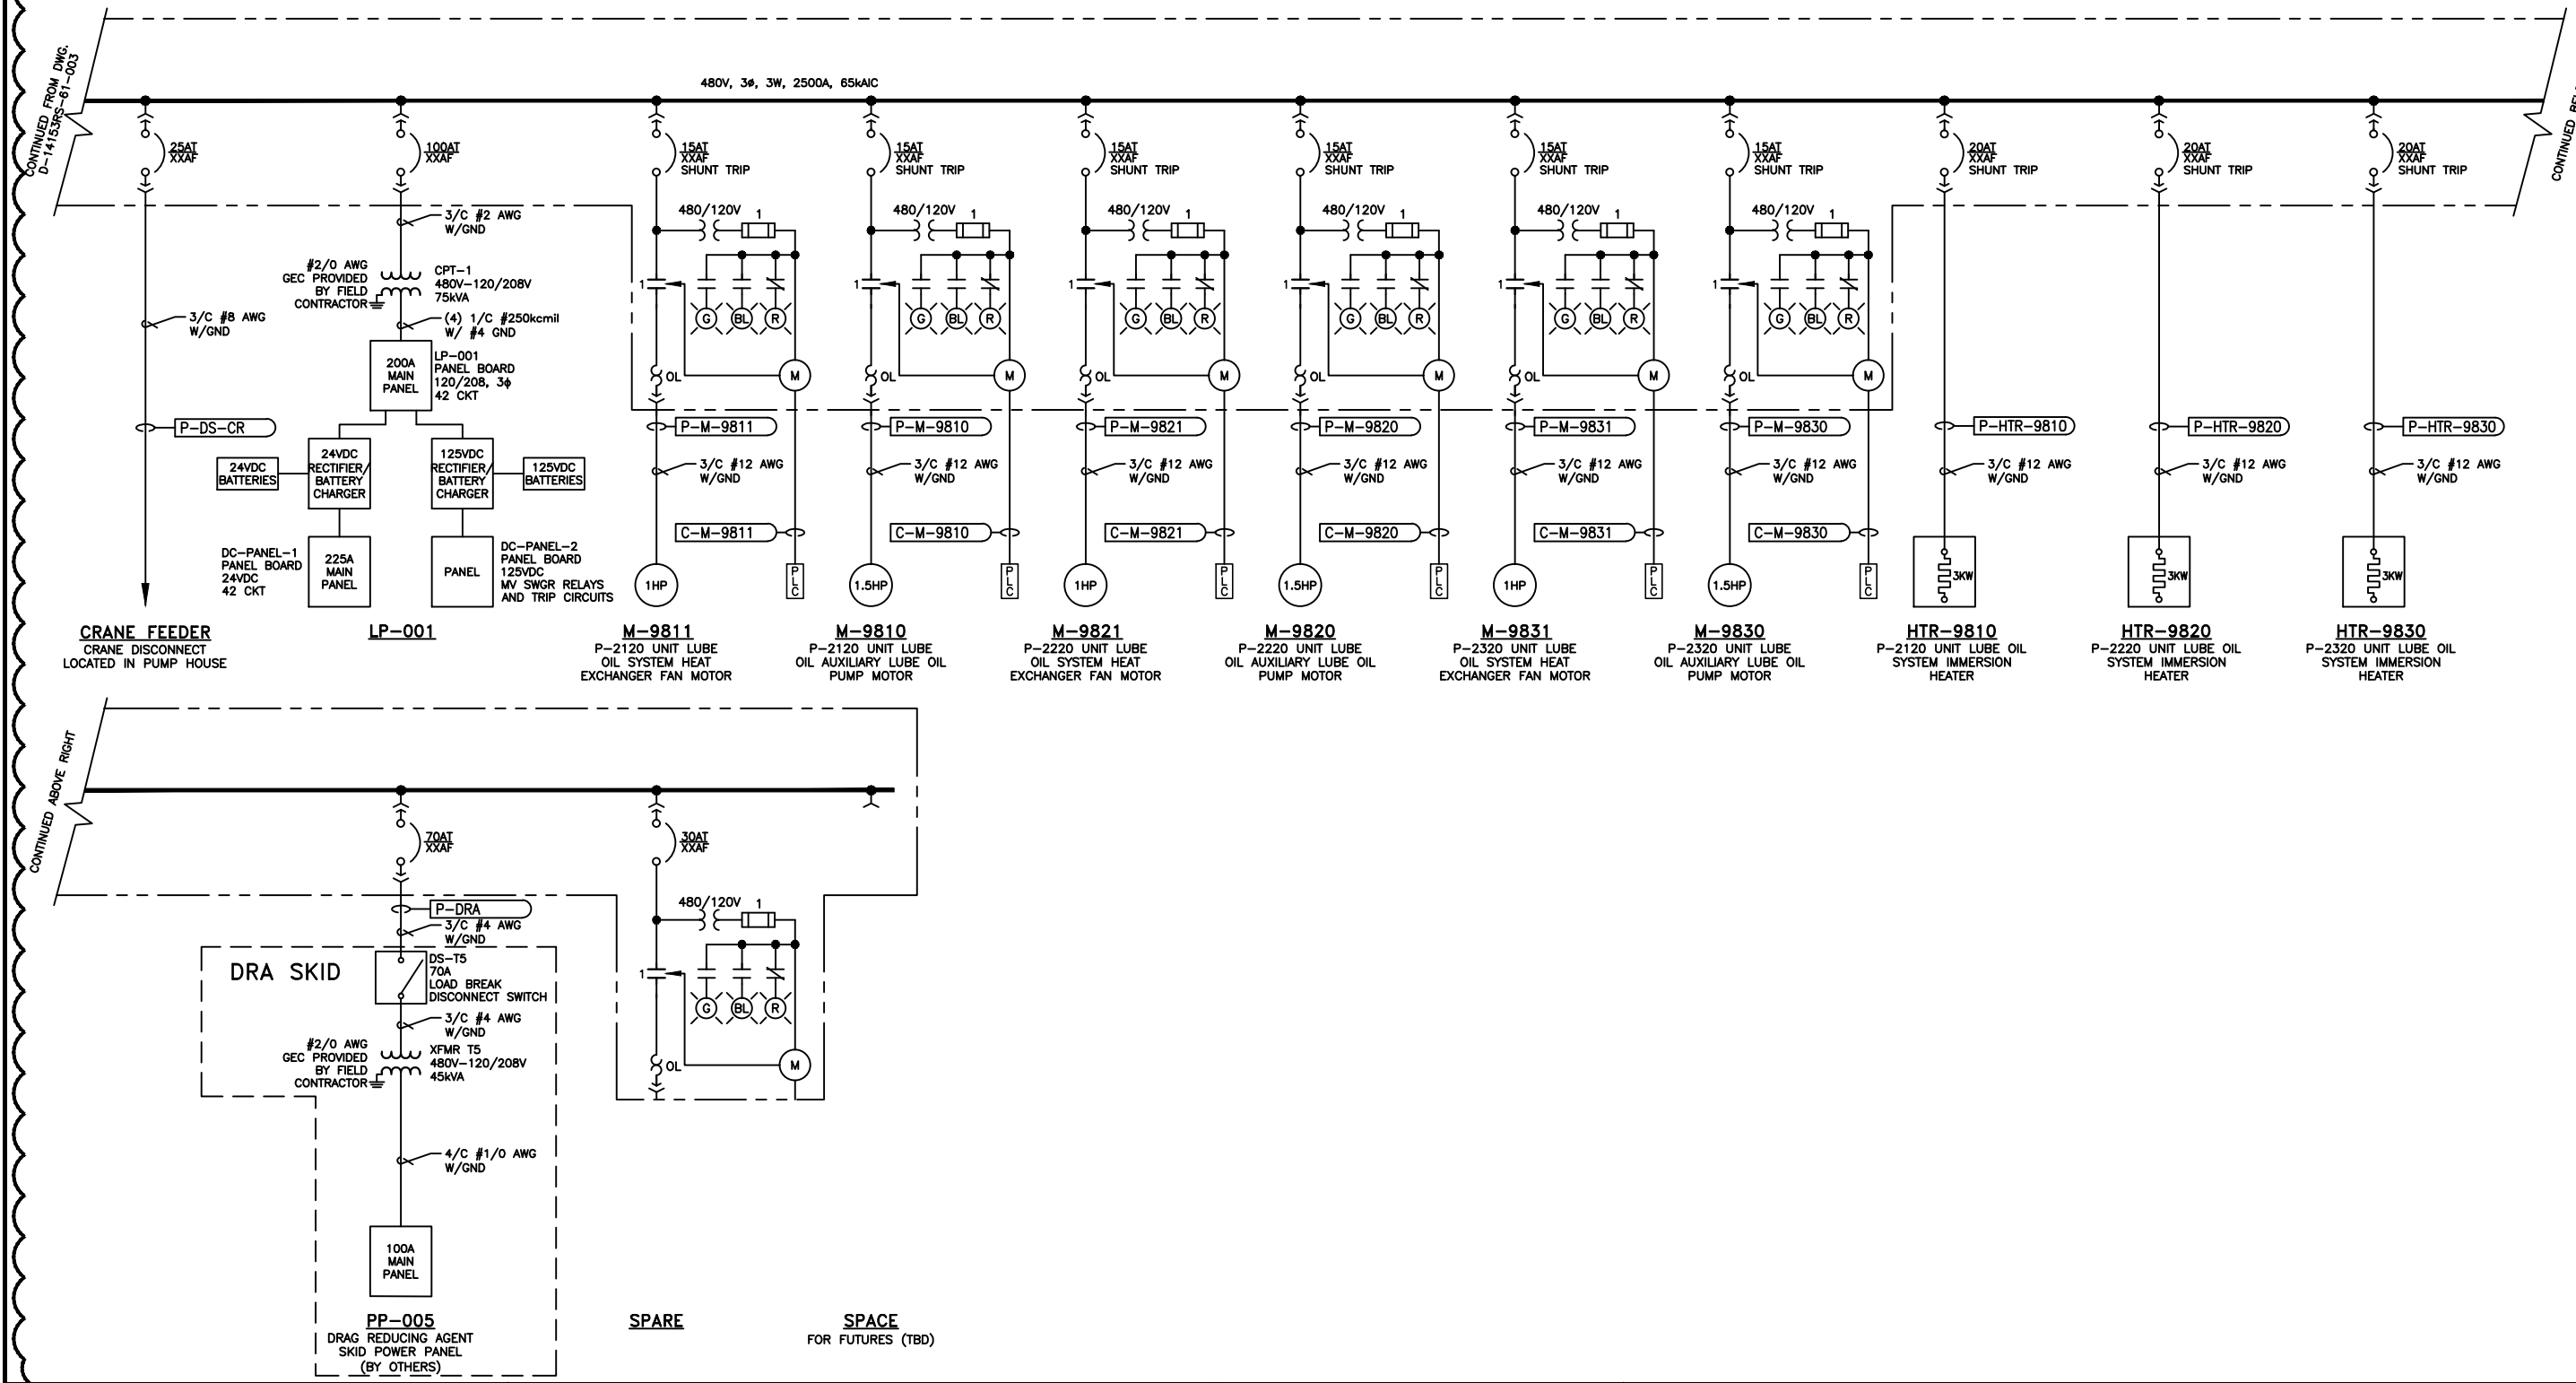

DWG. NO.	REFERENCE DRAWING TITLE	NO.	A PRELIMINARY	REVISION - DESCRIPTION	TML	06/30/15	SB	BY	DATE	CHK'D	APP'D	CADD	PLOT DATE:	FILE NAME: D-14153RS-61-004.dwg	SCALE: NONE	ENERGY TRANSFER M S BENBOW AND ASSOCIATES METAIRIE, LA	DAKOTA ACCESS PIPELINE REDFIELD STATION ELECTRICAL 480V ONE-LINE DIAGRAM SHEET 2 OF 2	PREVIOUS DWG. NO.
																		SHEET 1 OF 1
																		D-14153RS-61-004
																		SHEET 2 OF 2

6/29/2015 3:39 PM 14153 0 TML